

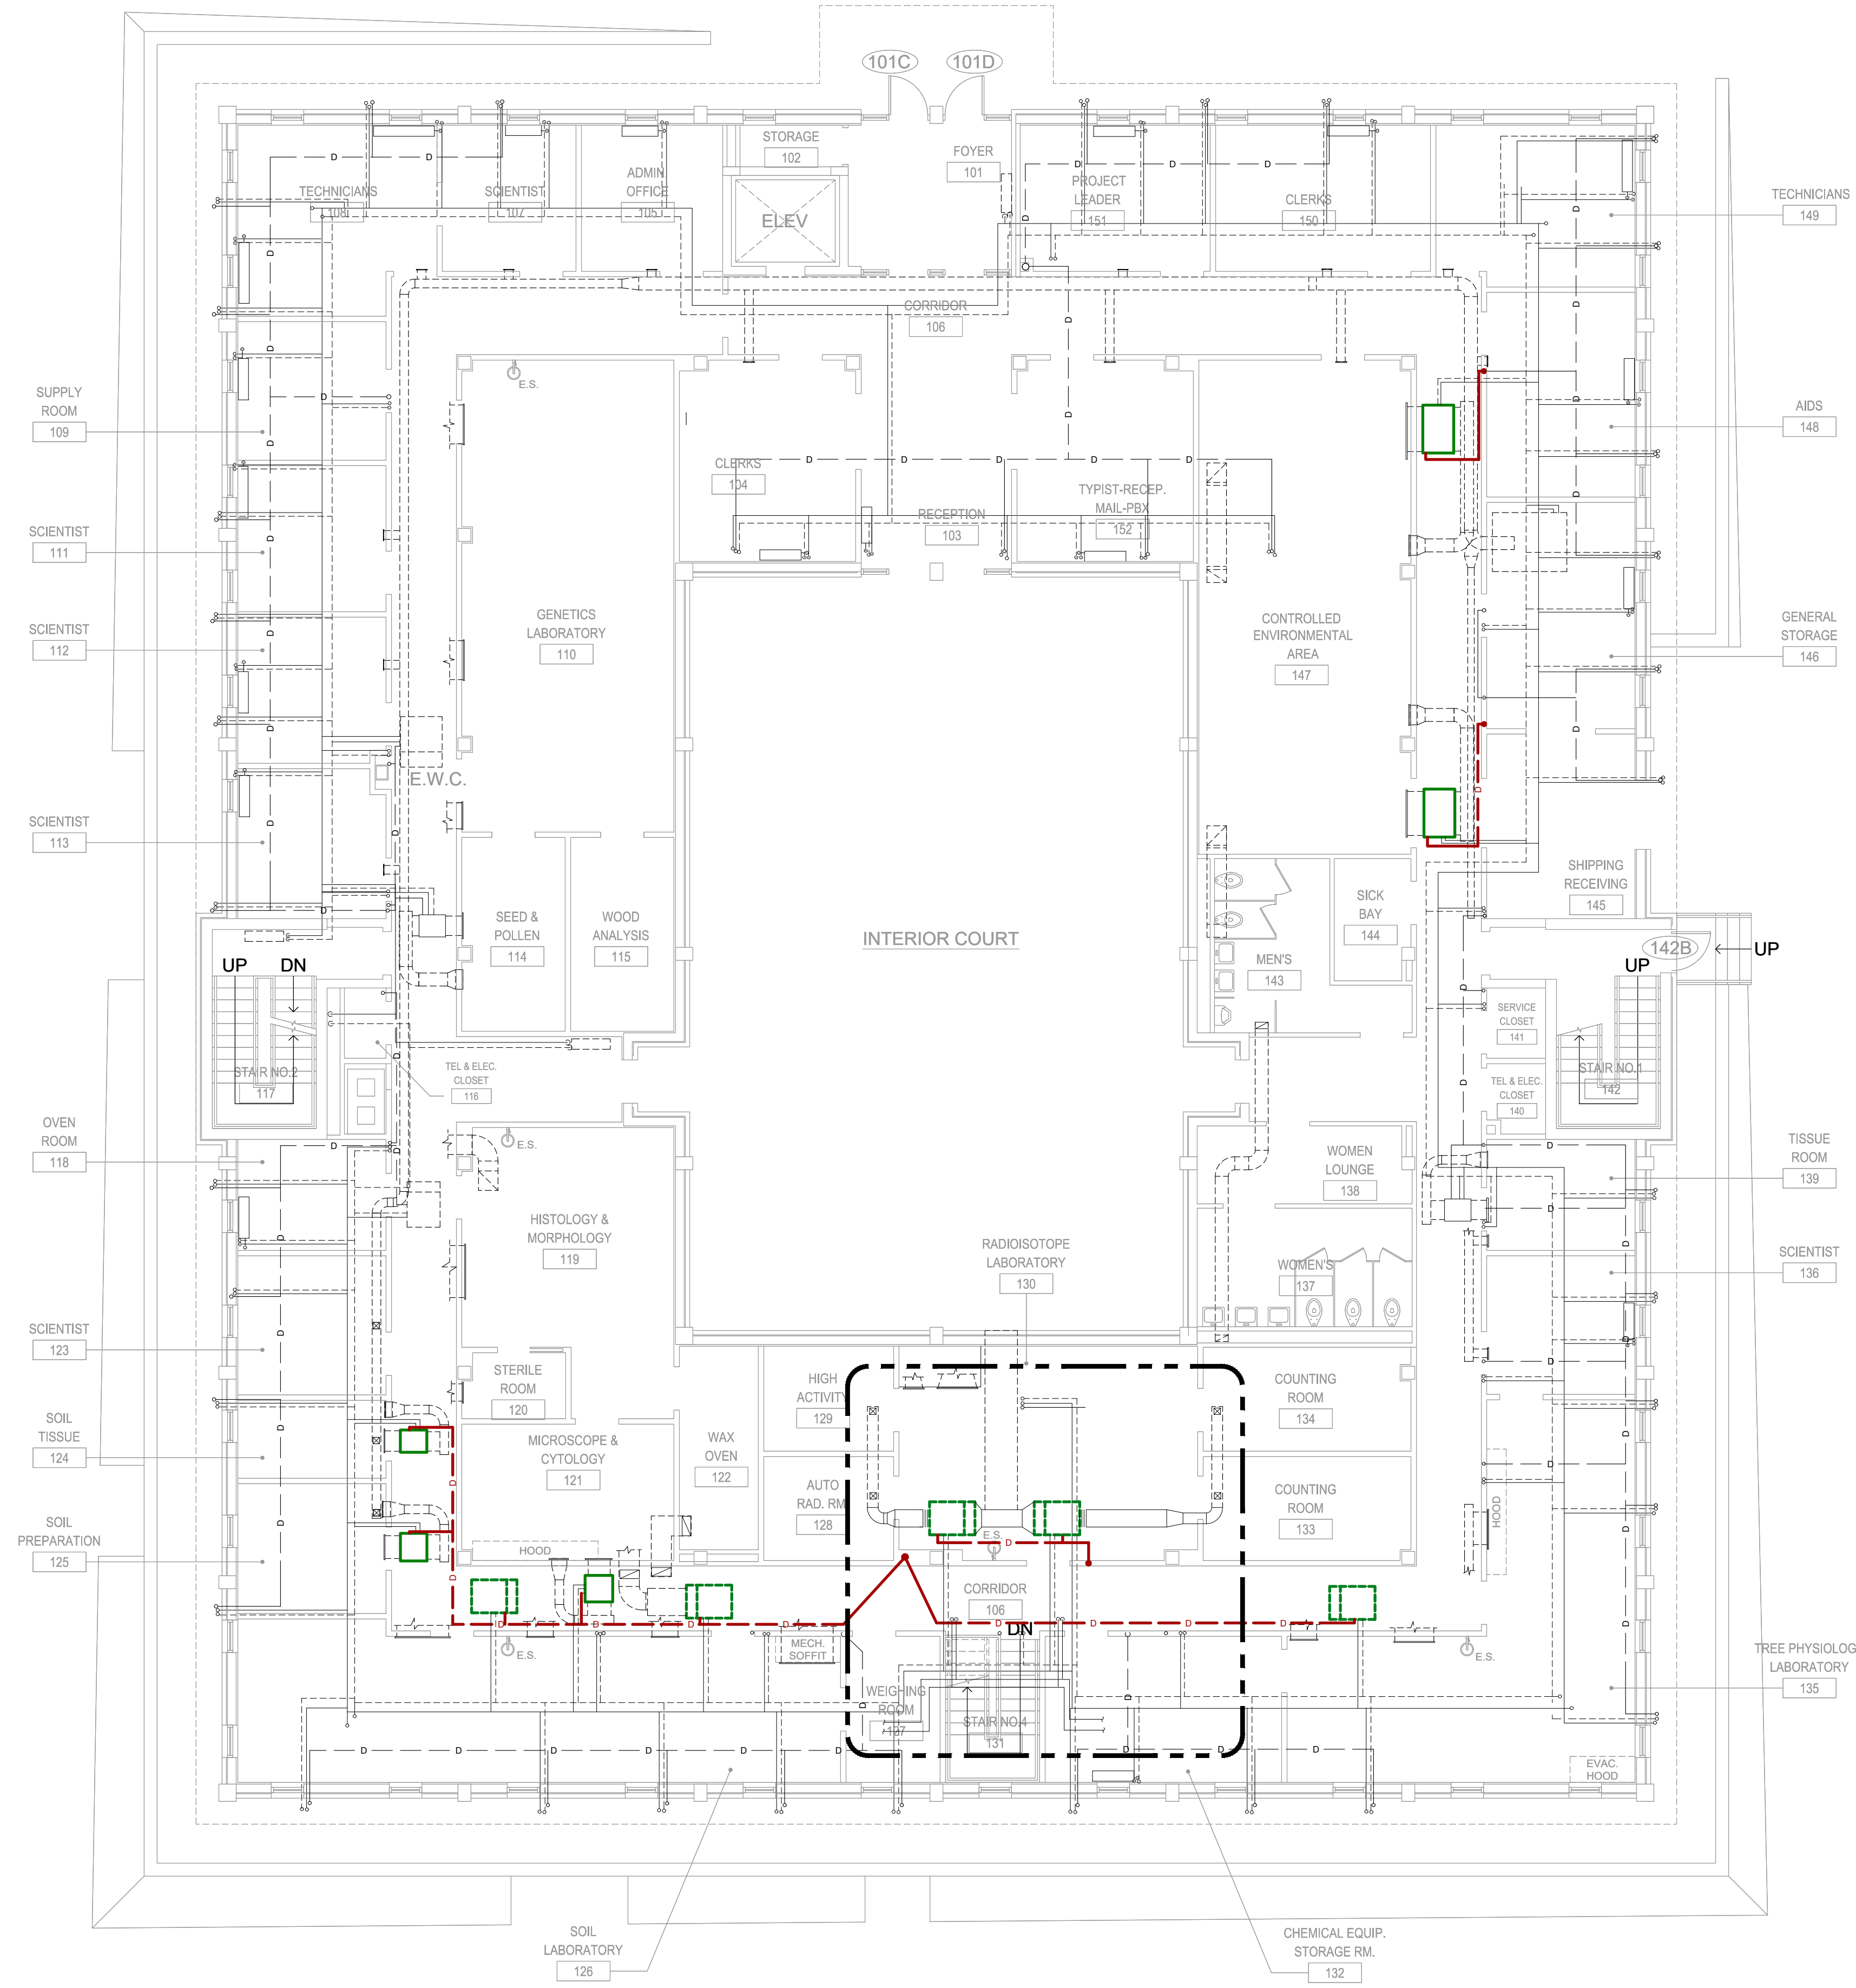


C:\Users\jmulryne\AppData\Local\Temp\AcPublish_26000\M-152A (Floor 1, existing).dwg jmulryne 04/02/24 - 10:52 A

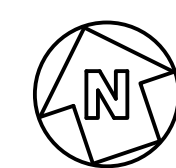


LEGEND

- CONDENSATE DRAIN, EXISTING
- CONDENSATE DRAIN, PROPOSED

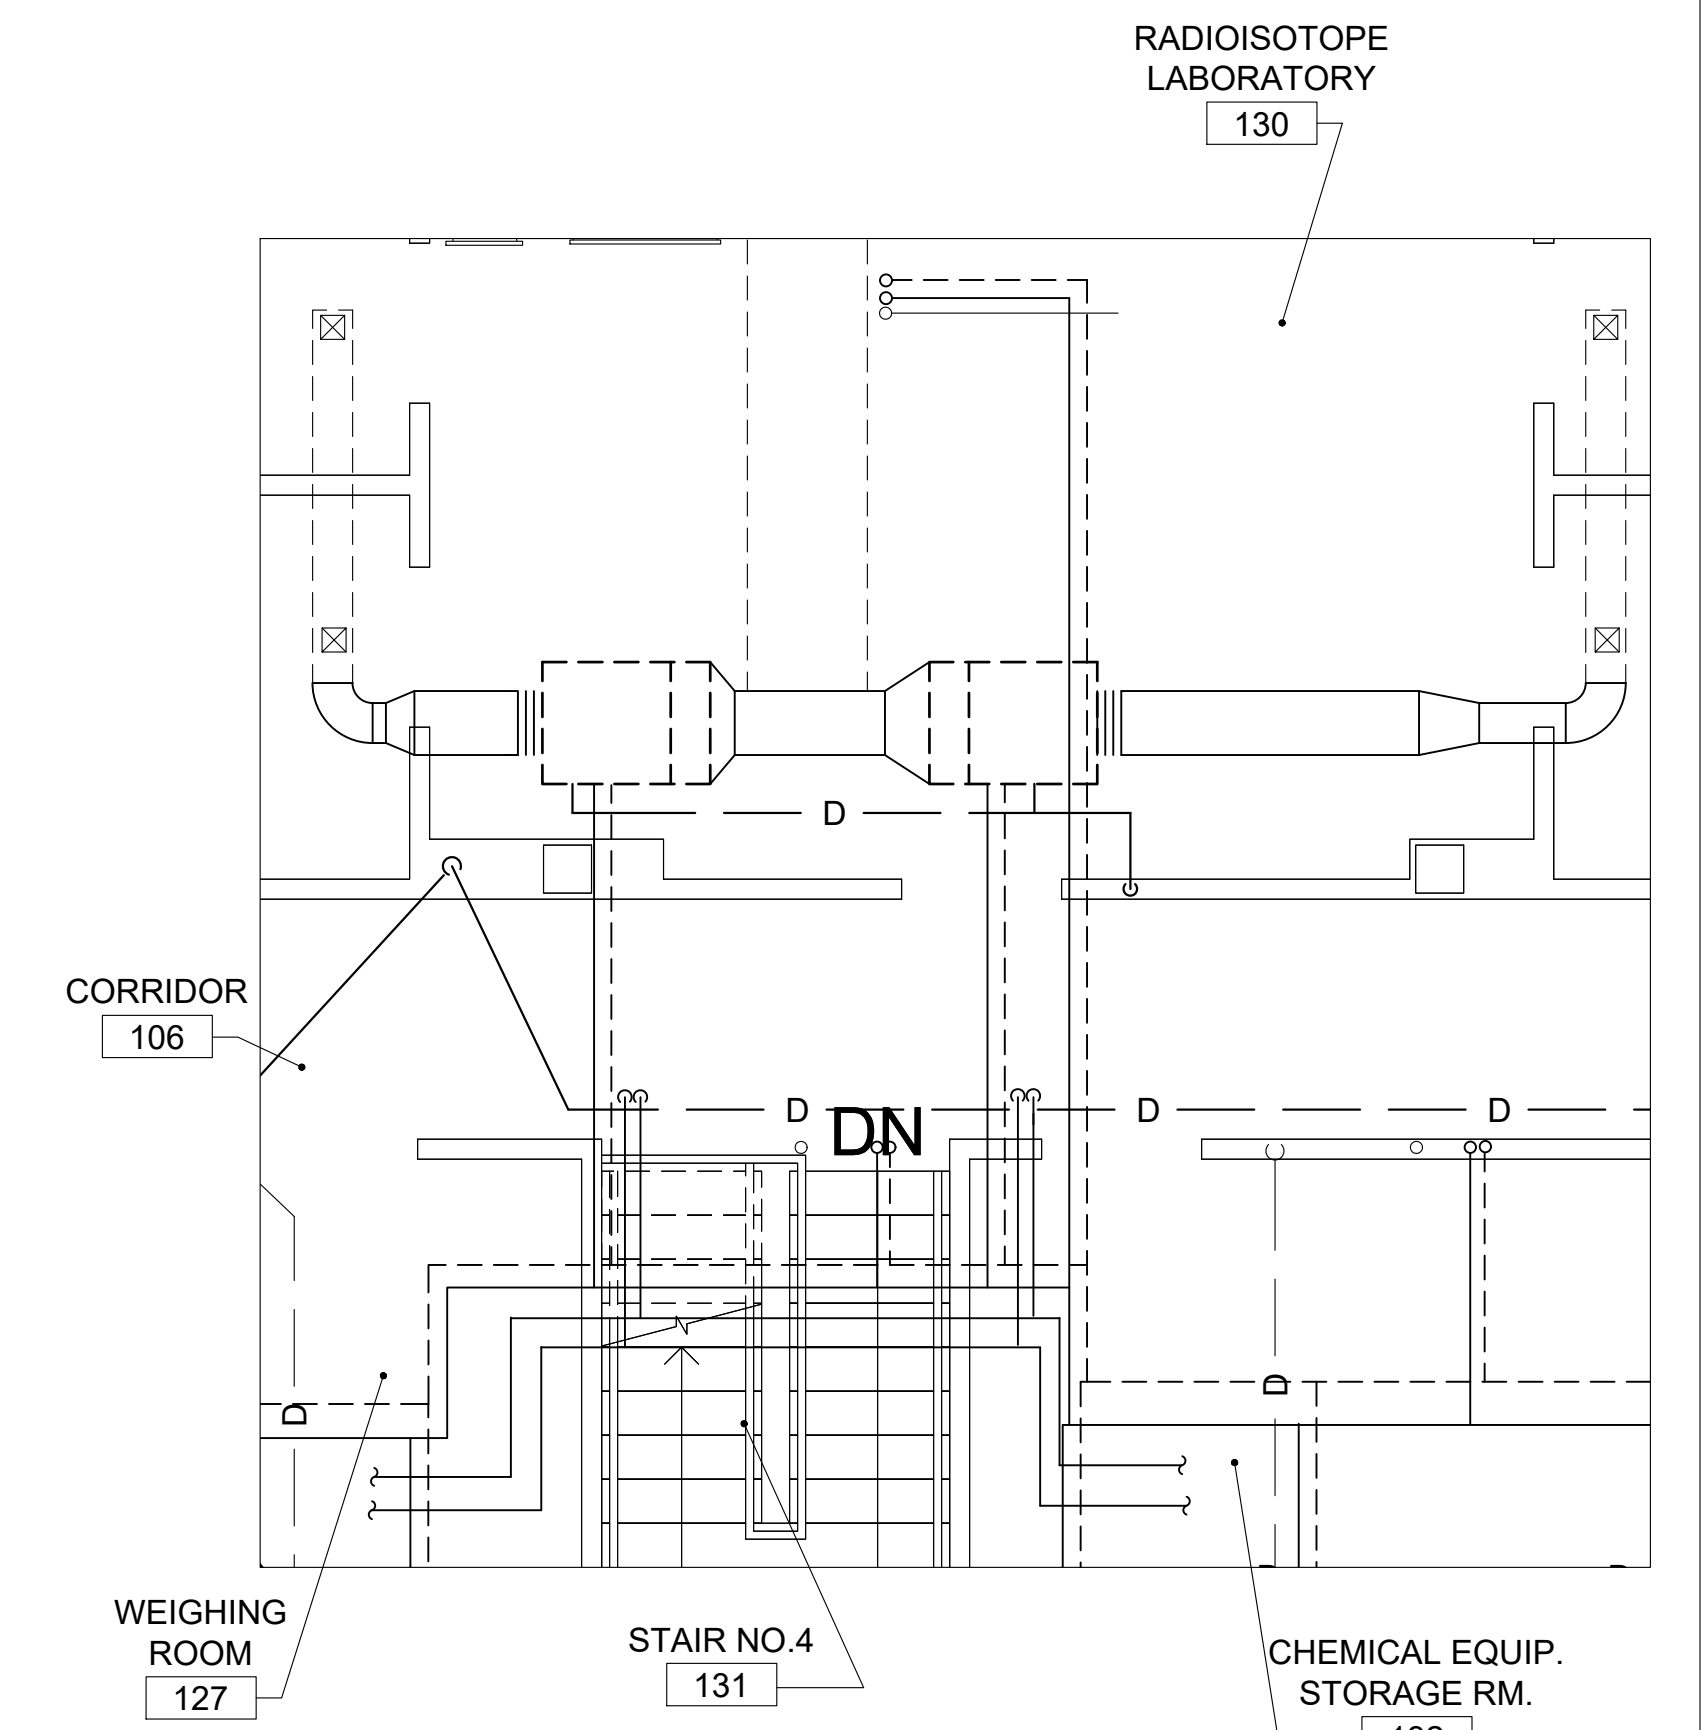

1 NORTH BUILDING FIRST FLOOR, HVAC EXISTING
M-152 SCALE: 1/8" = 1'-0"

2 ENLARGED FIRST FLOOR PART PLAN
M-152 SCALE: 1/4" = 1'-0"

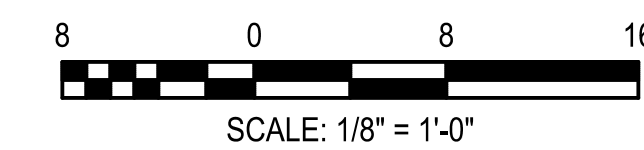


MARK	DATE	FOR CONST.	DESCRIPTION
1	01/31/2011		

PROJECT NO: 1110008
DRAWN BY:
CHECKED BY:

NORTH BUILDING
MECHANICAL
FIRST LEVEL

C:\Users\jmulryne\AppData\Local\Temp\AcPublish_28428\M-153A (Floor 2, existing).dwg jmulryne 03/11/24 - 2:58 P

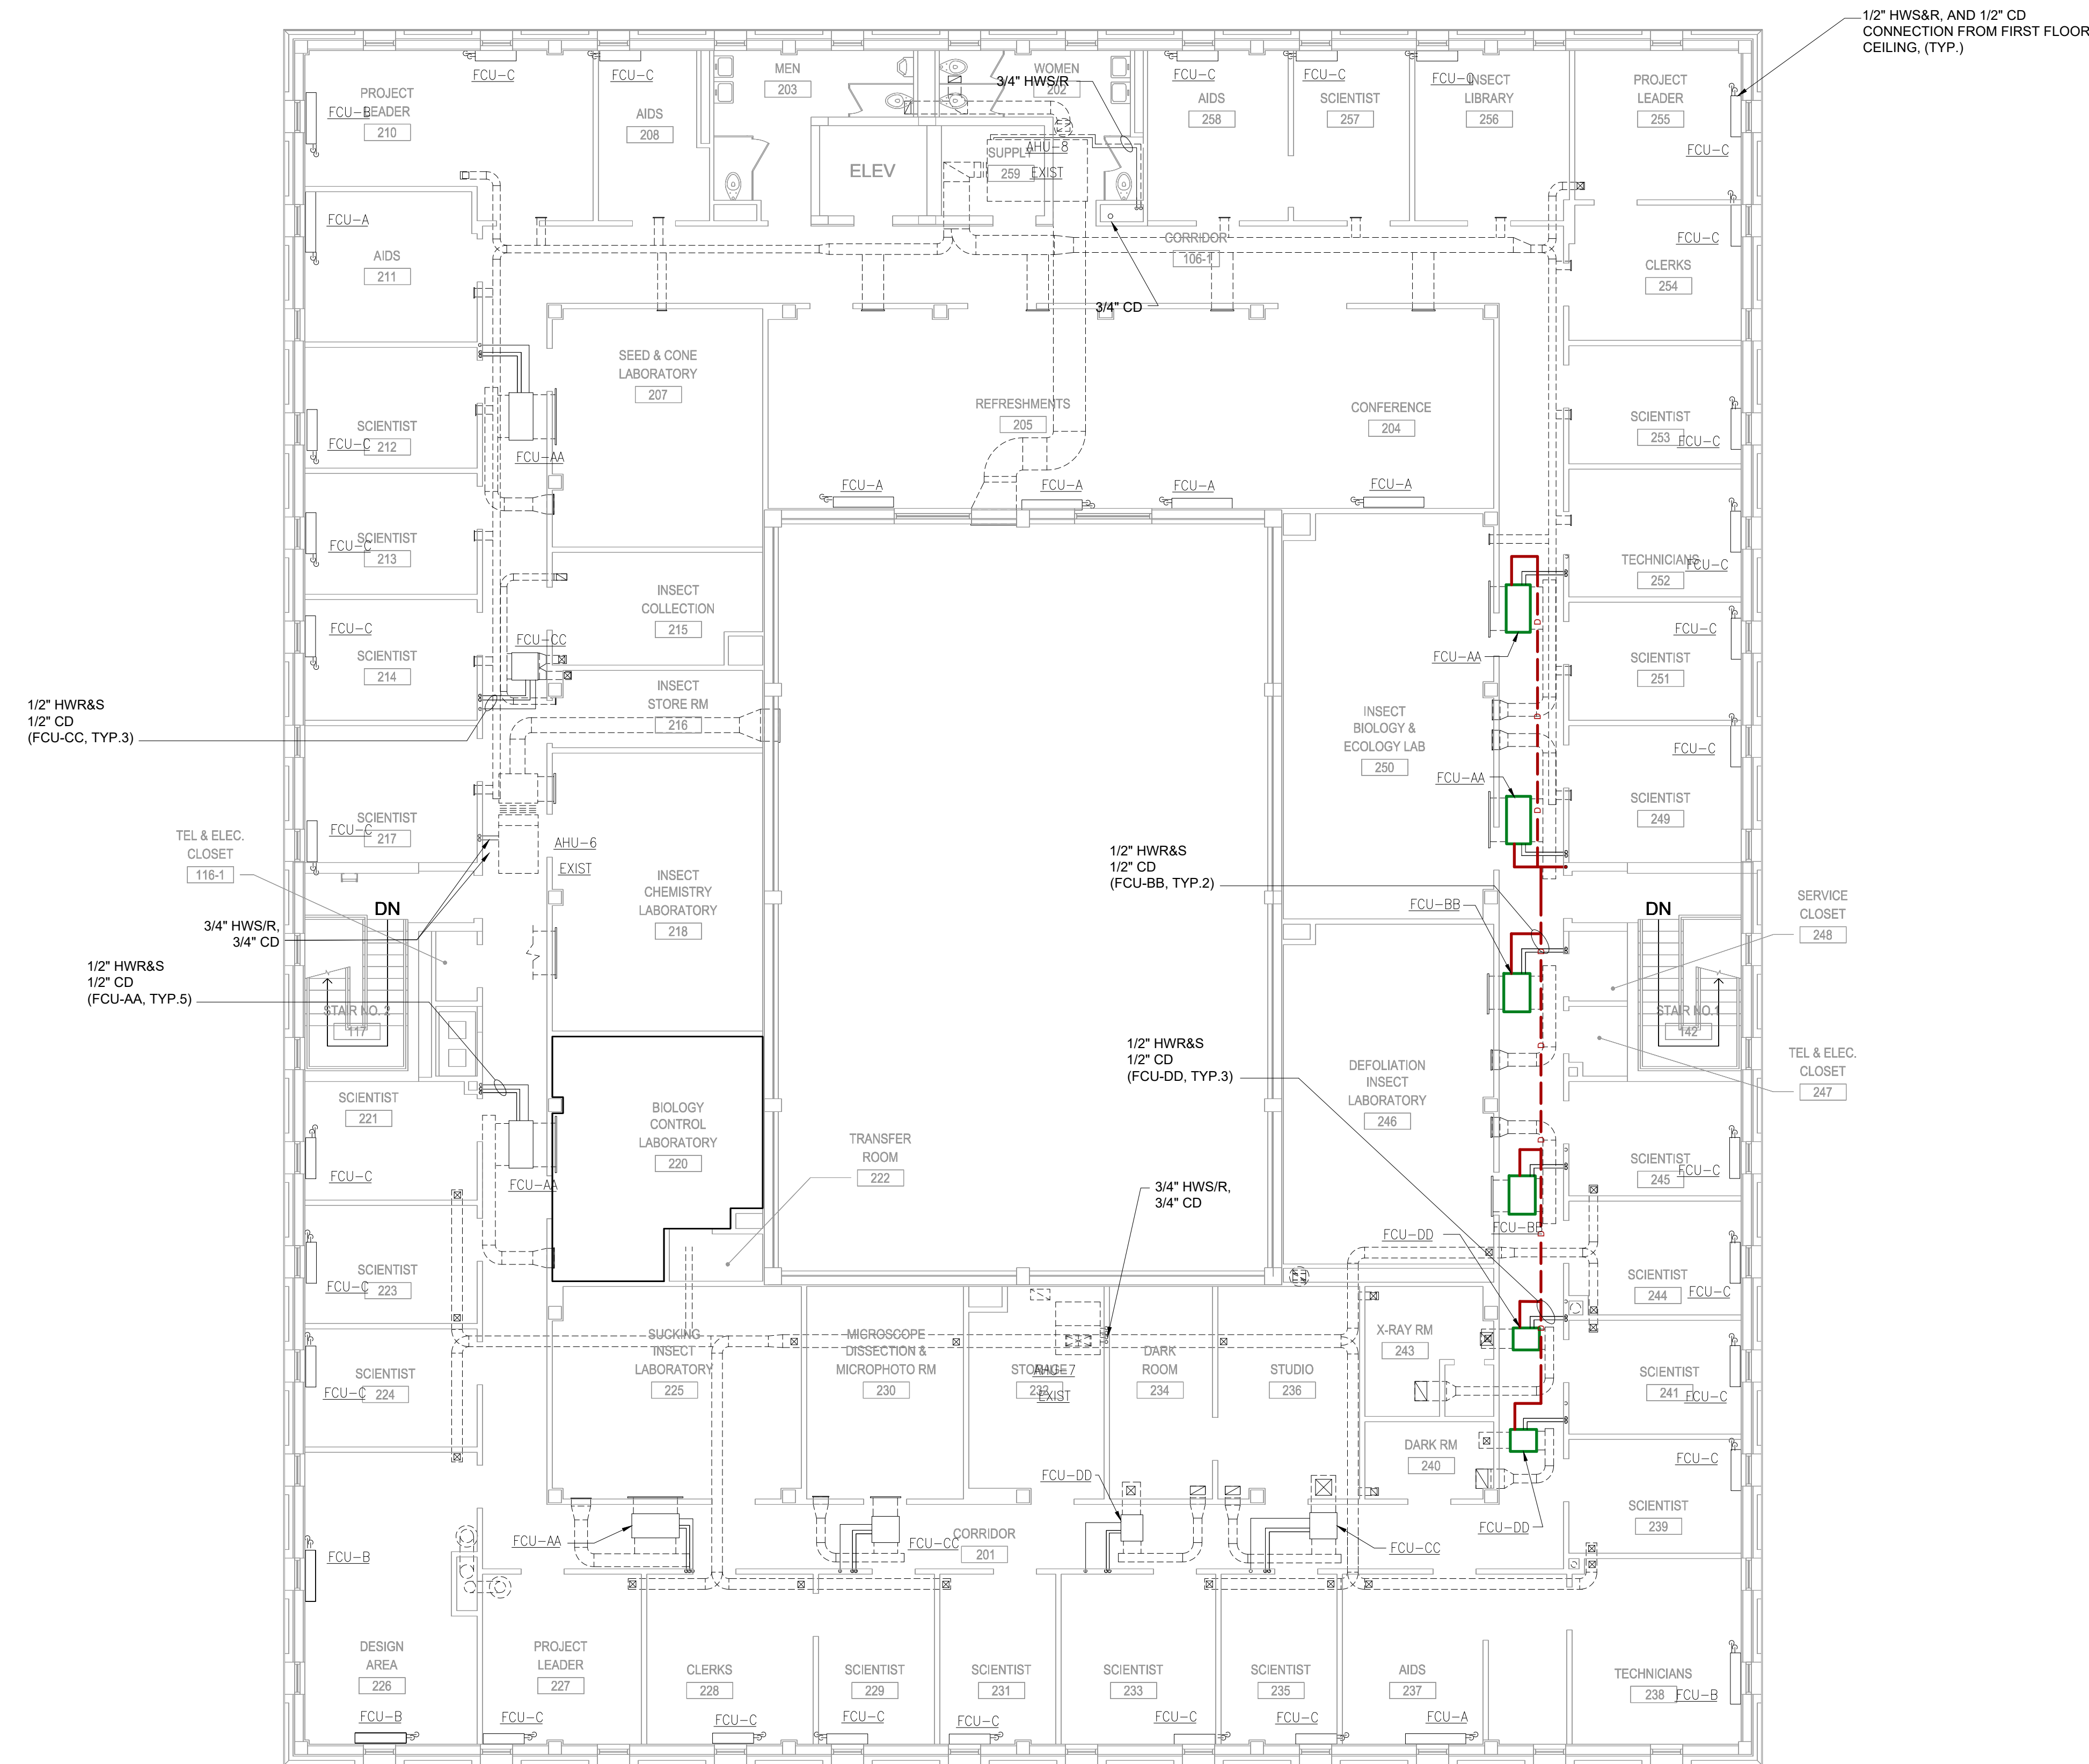


KEYED NOTES

- 1 CONDENSATE DRAIN LINE DOWN AND CONNECT TO EXISTING ROOF DRAINAGE.



1
M-153 NORTH BUILDING SECOND FLOOR PLAN
SCALE: 1/8" = 1'-0"

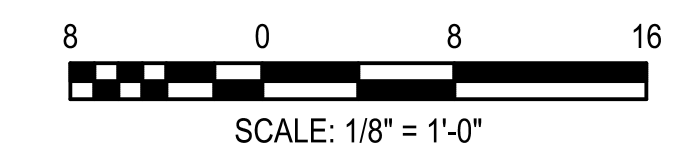

MARK	DATE	FOR CONST.	DESCRIPTION
1	01/31/2011		

PROJECT NO: 1110008
DRAWN BY:
CHECKED BY:

NORTH BUILDING
MECHANICAL
SECOND LEVEL