

Barksdale Air Force Base Louisiana

APPROVED

Signature	OFFICE
Engineer	
Chief of Engineering	
Chief of Design	
Contracting	
User	

COORDINATION

Architect	
Ground	
Soil	
Communication	
Contractors	
Environmental	
Engineer	
Police	
Security	
Systems	
Fire Chief	
Chief of Operations	
Construction Management	
Roofing	
Painting	
Corrosion	
Engineer	
Protection	
Coating, Eng.	

DESIGN FIRM

GUERNSEY
C.H. GUERNSEY & COMPANY
Engineers - Architects - Consultants
5555 North Grand Boulevard
Oklahoma City, OK 73112-9507
405-947-5515





Designer	M. KITCHEN	Project Manager	M. KITCHEN
Drawn	K. HANES	Date	FEB 96
REVISION		BY/DATE	

SHEET TITLE C304
FAMILY HOUSING LIFT STATION SITE PLAN

SHEET	41	OF	67
PROJECT TITLE	CONSTRUCT FAMILY HOUSING PHASES 3 & 4 UTILITIES UPGRADE BARKSDALE AIR FORCE BASE, LOUISIANA		
Project Number	AWUB967001	AWUB977001	
Drawing Number	B96/97-8000-2	Faculty Number	

NOTE: MAXIMUM DRAWING SIZE: 24" X 36" (600mm X 914mm) DATE: APR 96, 1996 TIME: 1:54 PM BY: K. HANES

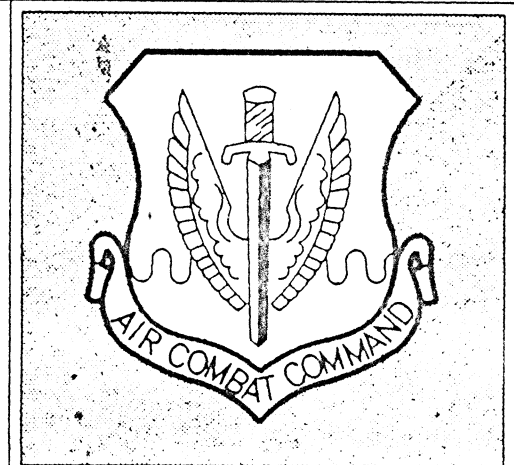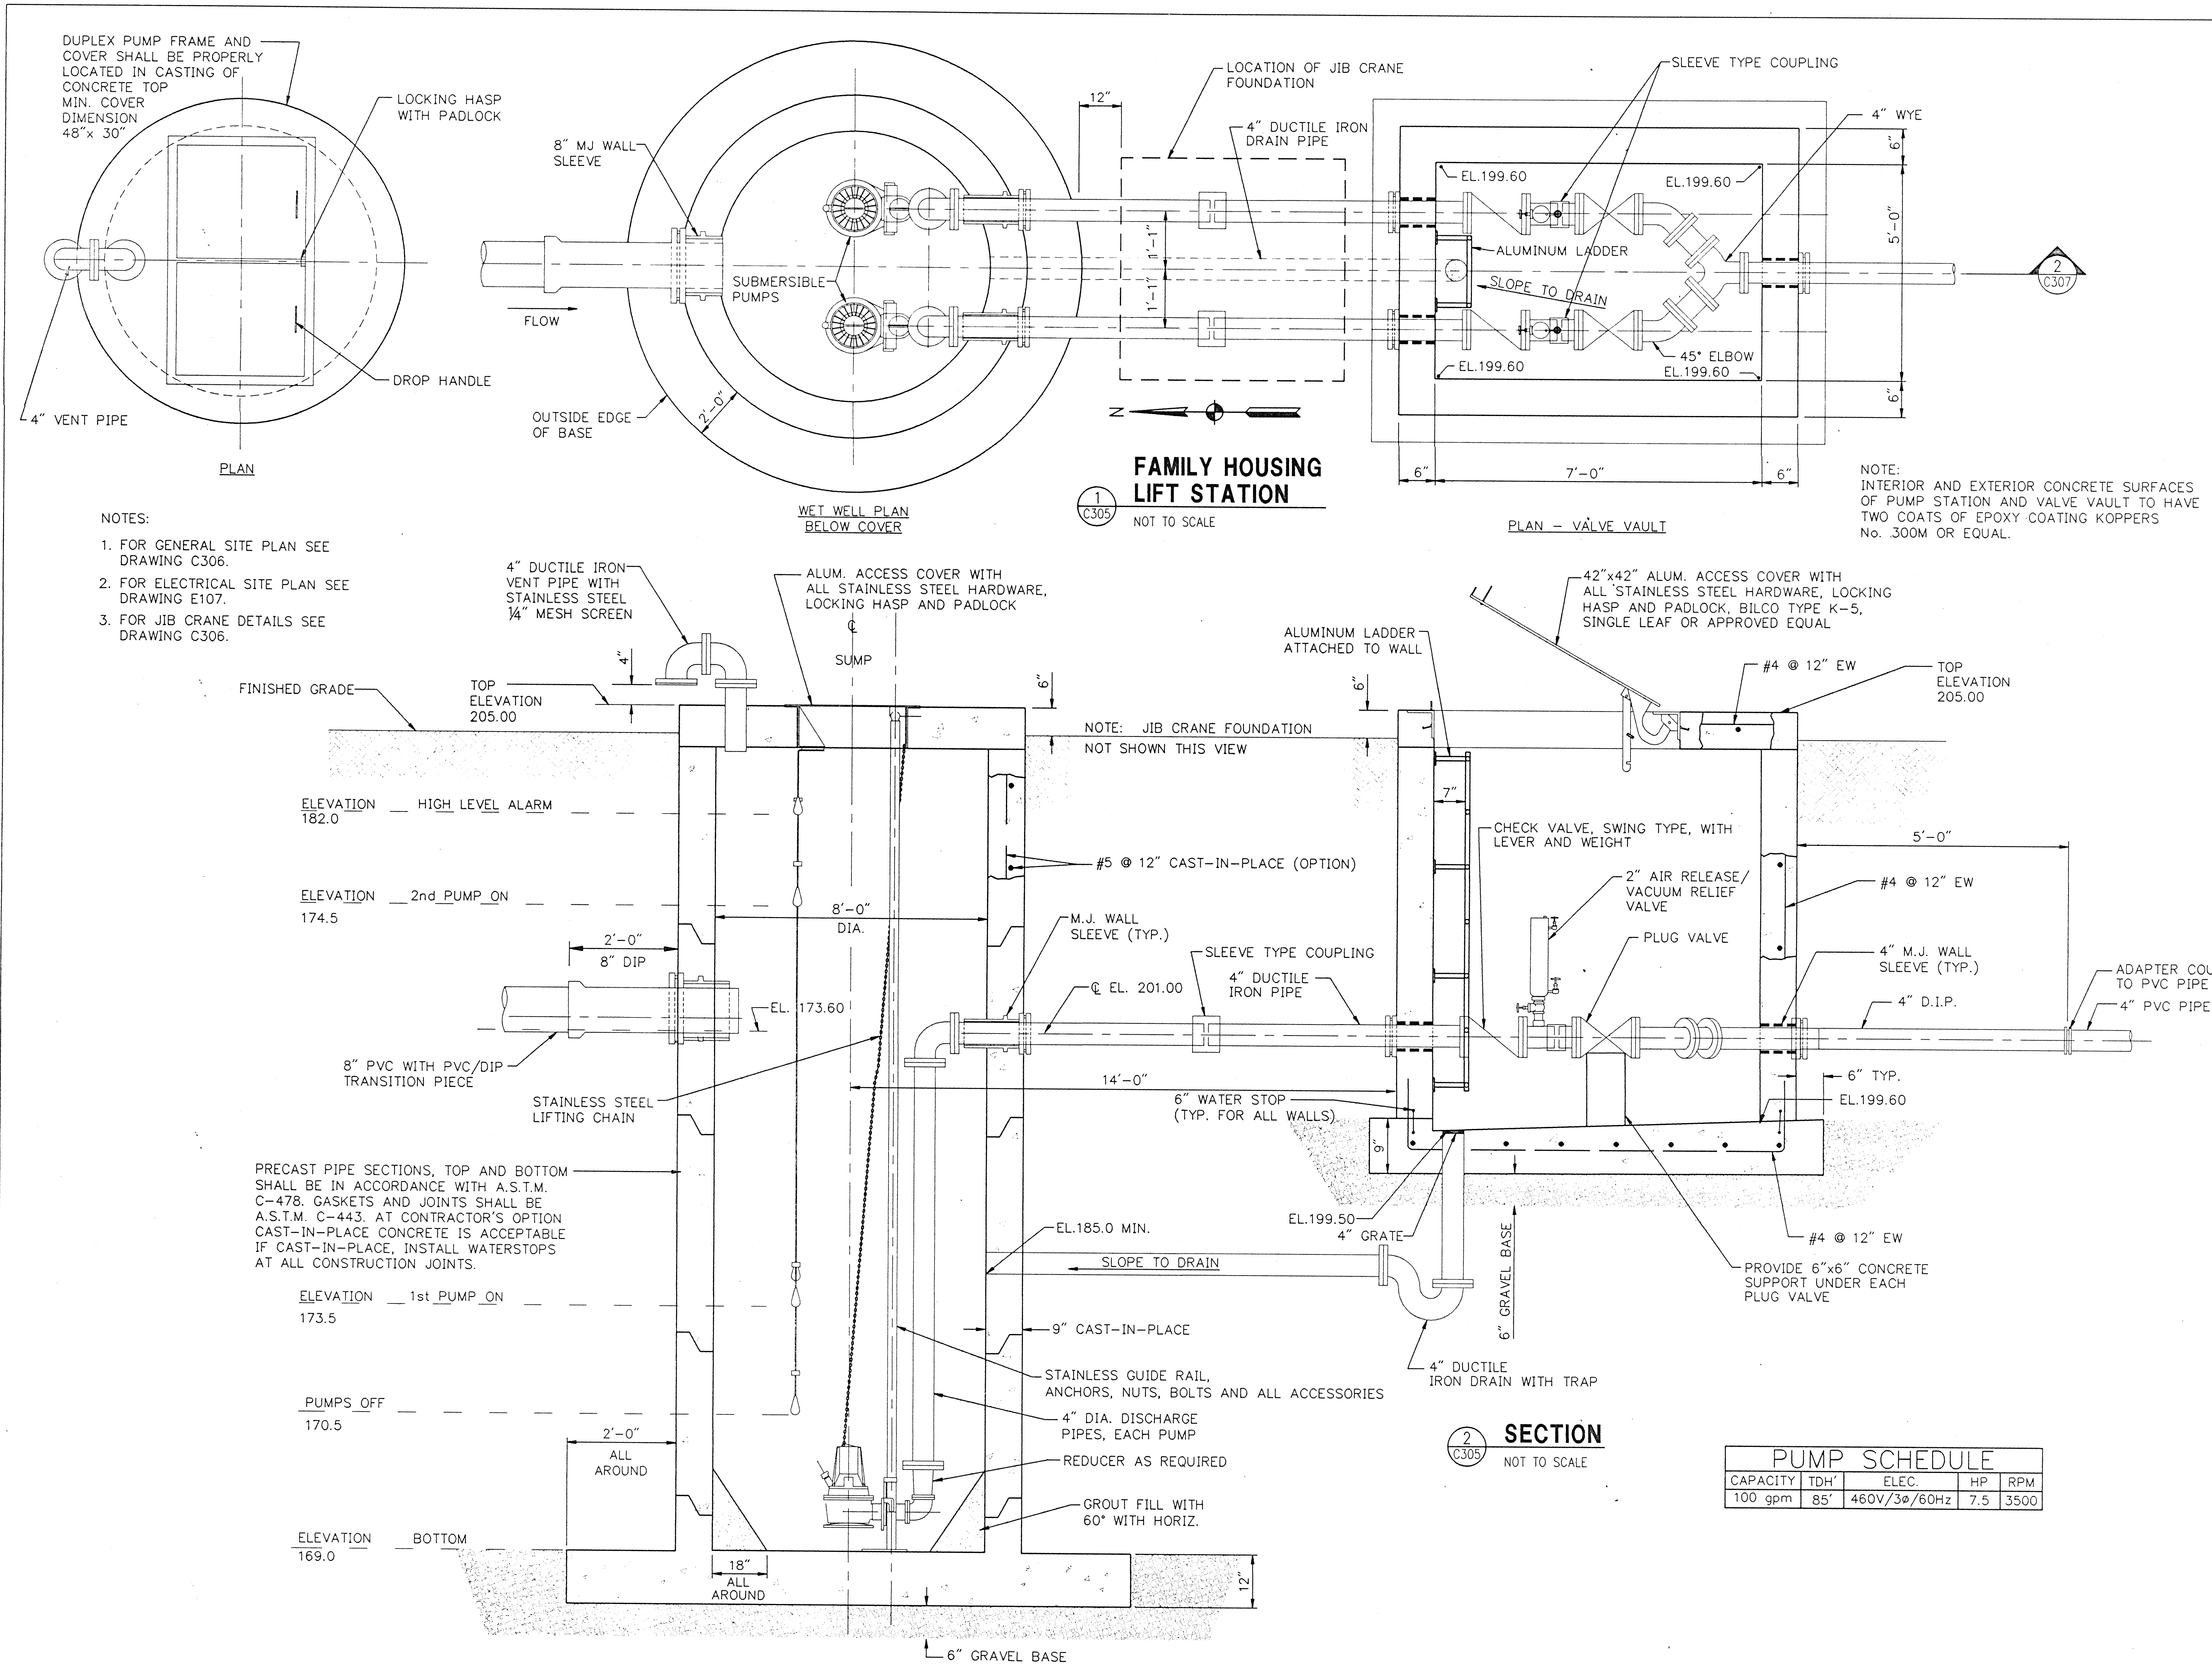

Barksdale
Air Force Base
Louisiana

APPROVED


SIGNATURE	OFFICE
	Civil Engineer
	Chief of Engineering
	Chief of Design
	Contracting
	User

COORDINATION

	Field Manager
	Ground Safety
	Communication Computers
	Environmental Engineer
	Security Systems
	Police
	Fire Chief
	Chief of Operations
	Construction Management
	Roofting Engineer
	Pavements Engineer
	Corrosion Engineer
	Protective Coating Engr.

DESIGN FIRM

GUERNSEY
 C.H. GUERNSEY & COMPANY
 Engineers - Architects - Consultants
 5555 North Grand Boulevard
 Oklahoma City, OK 73112-5507
 405-947-5515

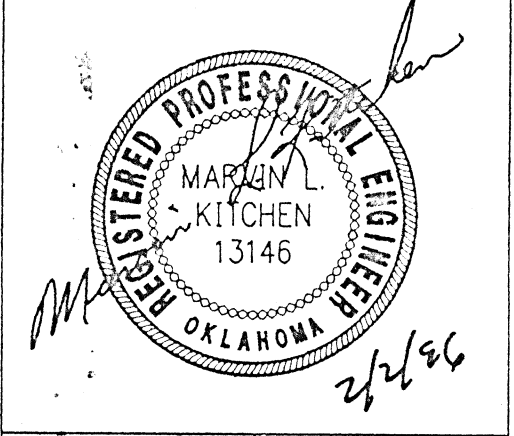

Designer M. KITCHEN	Project Manager M. KITCHEN
Author T. JOHNSON	Date FEB 96

REVISION	BY/DATE

SHEET TITLE
 FAMILY HOUSING
 LIFT STATION
 DETAILS

SHEET 42	OF 67
----------	-------

PROJECT TITLE
 CONSTRUCT FAMILY HOUSING
 PHASES 3 & 4
 UTILITIES UPGRADE
 BARKSDALE AIR FORCE
 BASE, LOUISIANA

Project Number
 AWUB967001
 AWUB977001

Drawing Number
 B96/97-8000-2

Facility Number